

SCALE:

CONSULTANT:

KEY PLAN:

THIS DOCUMENT IS THE PROPERTY OF VEDDELAGO PATSCH ARCHITECTS. IT IS TO BE USED ONLY FOR THE PROJECT AND SITE SPECIFICALLY IDENTIFIED HEREIN. IT IS NOT TO BE REPRODUCED, COPIED, EITHER WHOLLY OR IN PART, OR TRANSMITTED IN ANY FORM OR BY ANY MEANS, ELECTRONIC OR MECHANICAL, INCLUDING PHOTOCOPYING, RECORDING, OR BY ANY INFORMATION STORAGE AND RETRIEVAL SYSTEM, WITHOUT THE WRITTEN PERMISSION OF VEDDELAGO PATSCH ARCHITECTS.

PROJECT NAME:
**LAS VEGAS UROLOGY
TENANT IMPROVEMENTS**
7150 West Sunset Road. Las Vegas NV, 89118

SHEET TITLE:
OVERALL FLOOR PLAN

REV.	DESCRIPTION	DATE

Project No: 2007125
Drawn By: VPA
Date: 04-13-2008
Scale: AS NOTED
Sheet No: **A2.01**

KEYNOTES

1. SINK PER PLUMBING
2. CASEWORK, SEE CUSTOMER DRAWINGS
3. FINE PARTICULATES & CABINET
4. TOP OF CABINET @ 4'9" A.F.F.
5. ELECTRONIC WATER COOLER
6. SINK PER PLUMBING
7. CONTRACTOR TO DEMOLISH EXISTING 1-HR FIRE RESISTIVE WALL AS REQUIRED FOR NEW DOOR & WINDOW SYSTEM
8. CONTRACTOR TO KEEP SPACE CLEAR FOR FINISH ELECTROCK & OR PIPING
9. FINISH ELECTROCK PER DETAIL SVA1.2
10. TUBE STEEL POST PER DETAIL SVA1.2

EQUIPMENT LIST

NOTE:
REFER TO A04 SHEETS A04A-03 FOR ALL REQUIRED DIMENSIONS PERTAINING TO ACCESSORS AND HEIGHTS AND CLEARANCES


- (A) MIRROR IN STAINLESS STEEL FRAME
MIRROR TO BE MOUNTED TO EXISTING SURFACE @ MAX. A.F.F.
- (B) GRAB BAR
ADONG 5064-34 1/2" TO TOP OF GRAB BAR A.F.F.
- (C) GRAB BAR
ADONG 5064-34 1/2" TO TOP OF GRAB BAR A.F.F.
- (D) PAPER TOWEL DISPENSER AND WASTE RECEPTACLE
TUBOROCK 4838
@ 4' A.F.F. TO OPERATING PART
- (E) SANITARY WASH DISPENSER
TUBOROCK 4834
@ 4' A.F.F. TO OPERATING PART
- (F) SEQUENCE PASS THROUGH
VARN CORPORATION 497-120
@ 4' A.F.F. TO OPERATING PART
- (G) TOILET TISSUE DISPENSER
ADONG 4814-1/2" OF TOILET DISPENSER 8" IN FRONT OF WATER CLOSET
TUBOROCK 4838
- (H) SEAT COVER DISPENSER
TUBOROCK 4821
@ 4' A.F.F. TO OPERATING PART
- (J) LIQUID SOAP DISPENSER
TUBOROCK 48111
@ 4' A.F.F. TO OPERATING PART
- (K) PAPER TOWEL DISPENSER
TUBOROCK 483210
- (L) SHARPS CONTAINER
VERIFY W/ OWNER
- (M) GRAB BAR
TUBOROCK 4830X18
ANSI B04.5.1

LEGEND

- INDICATES WALL TYPE, SEE A2.01
- INDICATES SHAR FIRE RESISTIVE WALL
- INDICATES NEW INTERIOR STUD WALL

GENERAL NOTES

1. CONTRACTOR TO FIELD VERIFY ALL CONDITIONS PRIOR TO CONSTRUCTION
2. ALL DIMENSIONS ARE TAKEN FROM GRID, FACE OF STUD, MASSWORK, OR AT THE BATED PARTITIONS UNLESS OTHERWISE NOTED
3. APPROXIMATE FIRE STOPPING & FIRE CLOSURES, SEE FLOOR PLANS FOR BATHING & LOCATIONS
4. FINISH ELECTROCK, WOODWORK & PLUMBING FIXTURE IS ATTACHED TO THE WALL/WALL HANG.
5. SET INTERIOR GYPSUM BOARD AT ALL EXTERIOR WALLS TO BE FINISHED WITH GYPSUM BOARD. CONDUCT TESTS TO DETERMINE IF GYPSUM BOARD IS MILD RESISTANT TYPE GYPSUM BOARD AT RESTROOMS AND AREAS SUBJECT TO WETTING. PENETRATIONS OF RESISTIVE WALLS BE PROTECTED AS REQUIRED PER DETAIL SVA1.2

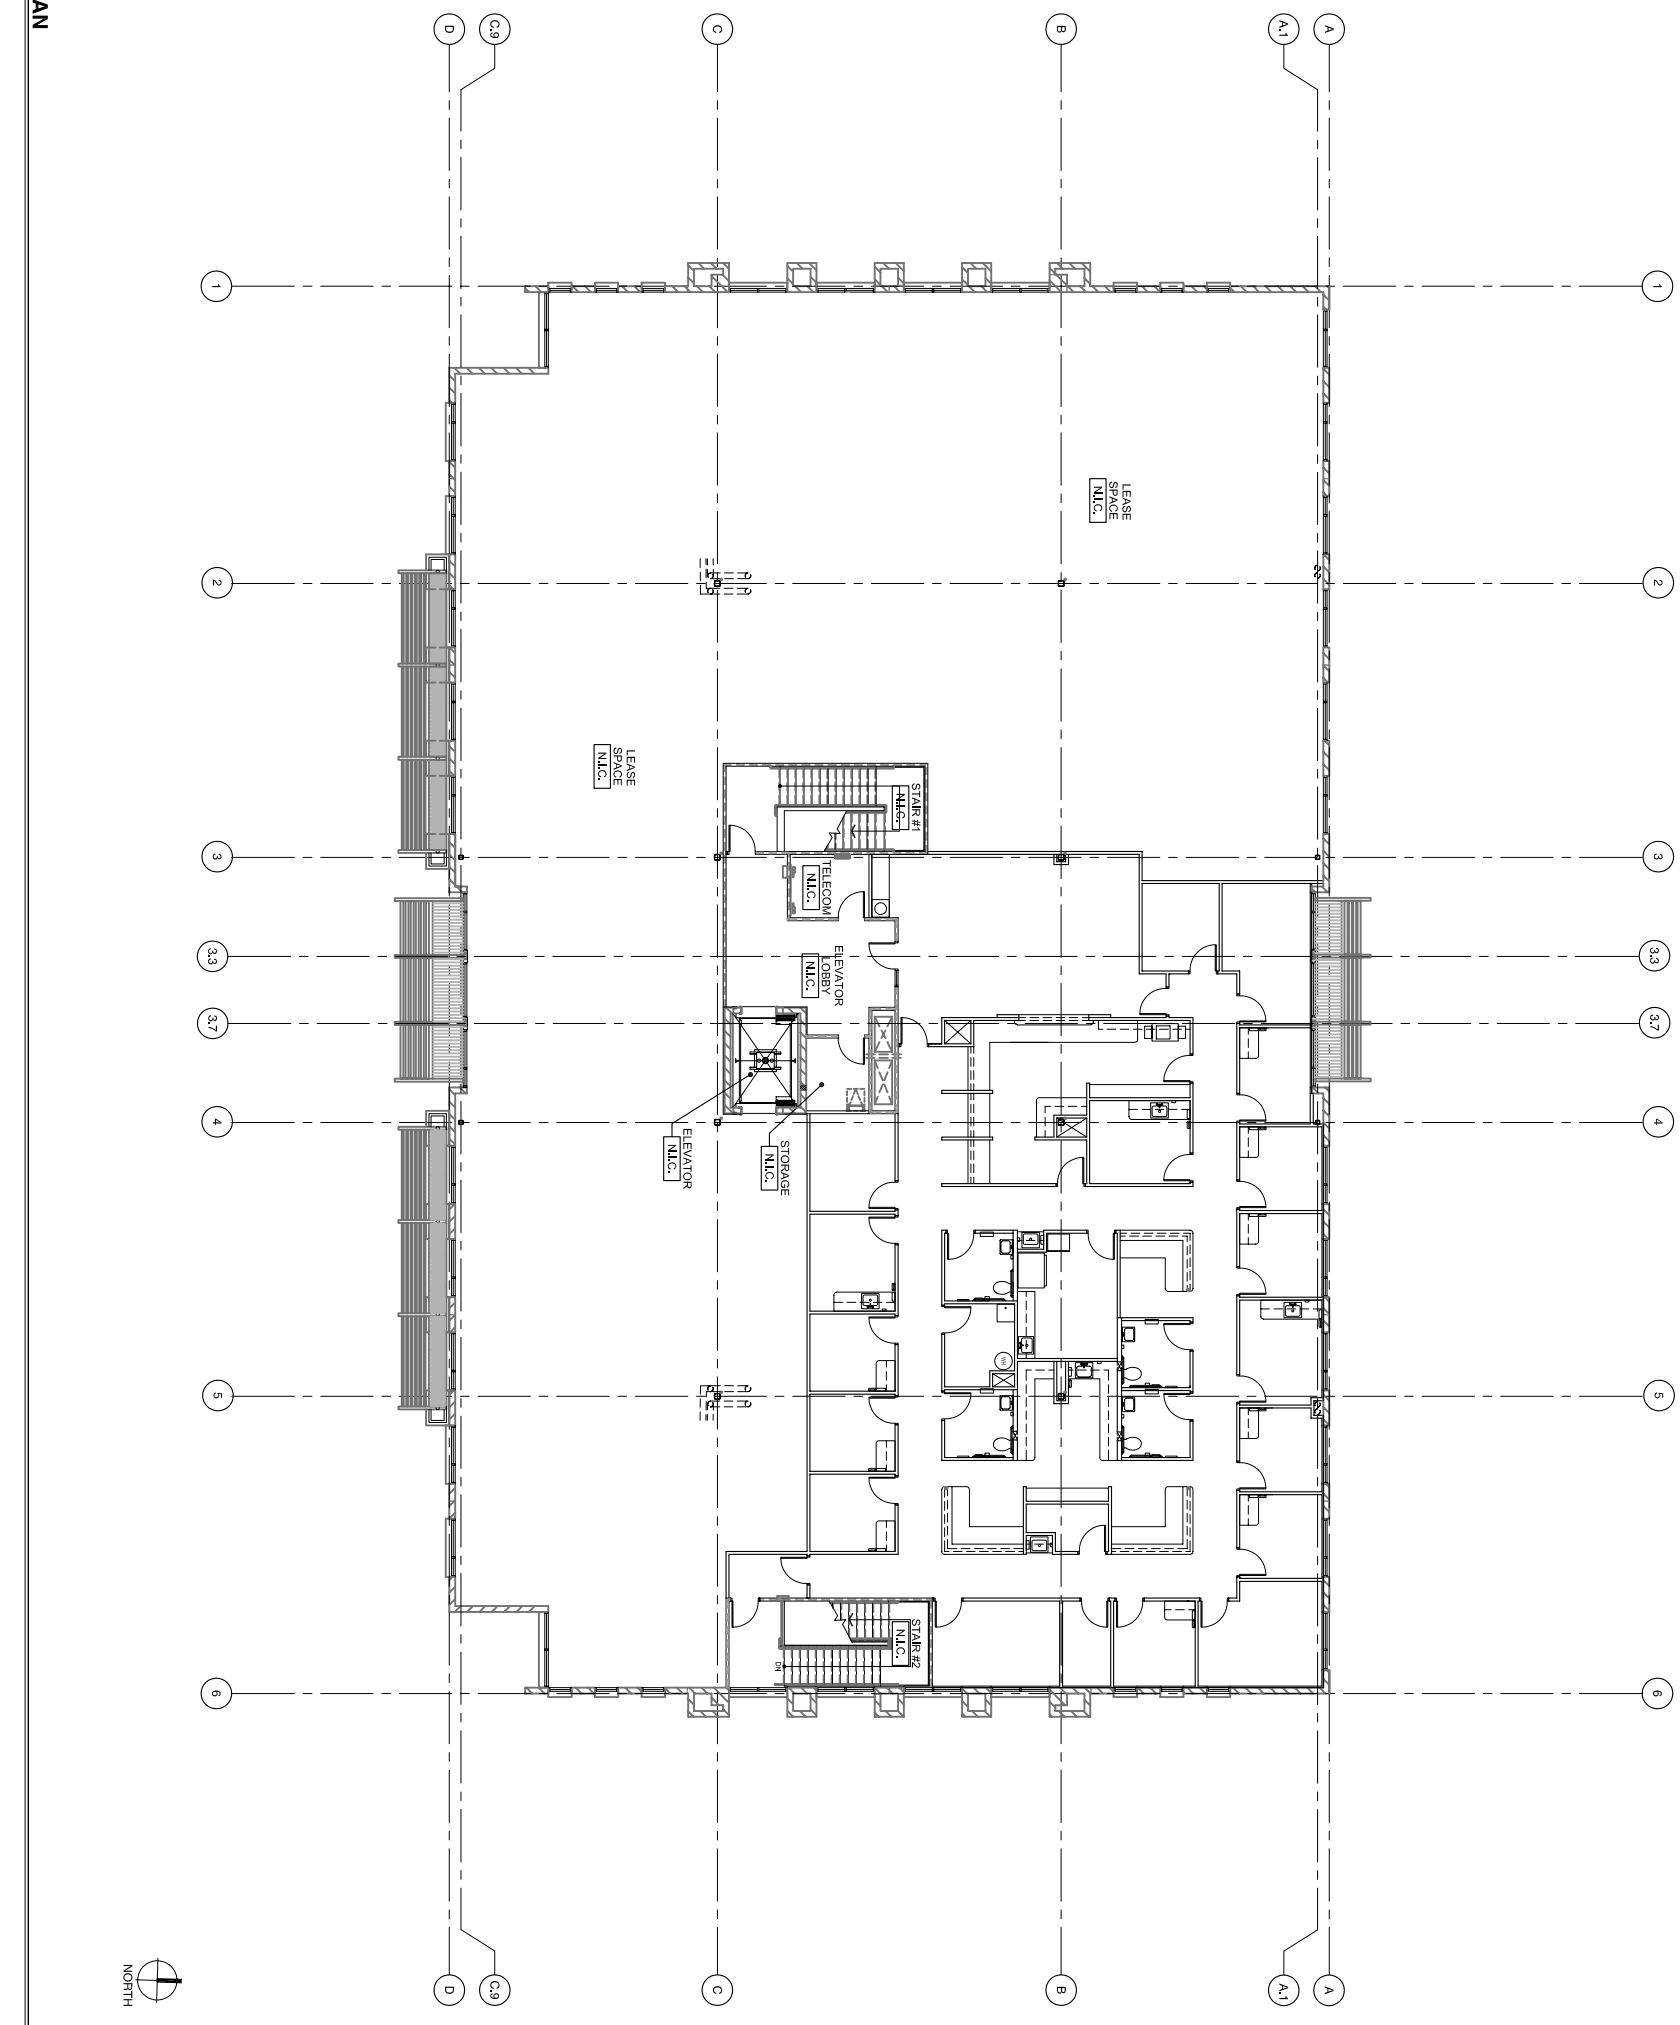

OVERALL FLOOR PLAN

SCALE: 1/8" = 1'-0"